


FLOOR PLAN-1  
SCALE 1:100



FLOOR PLAN -1

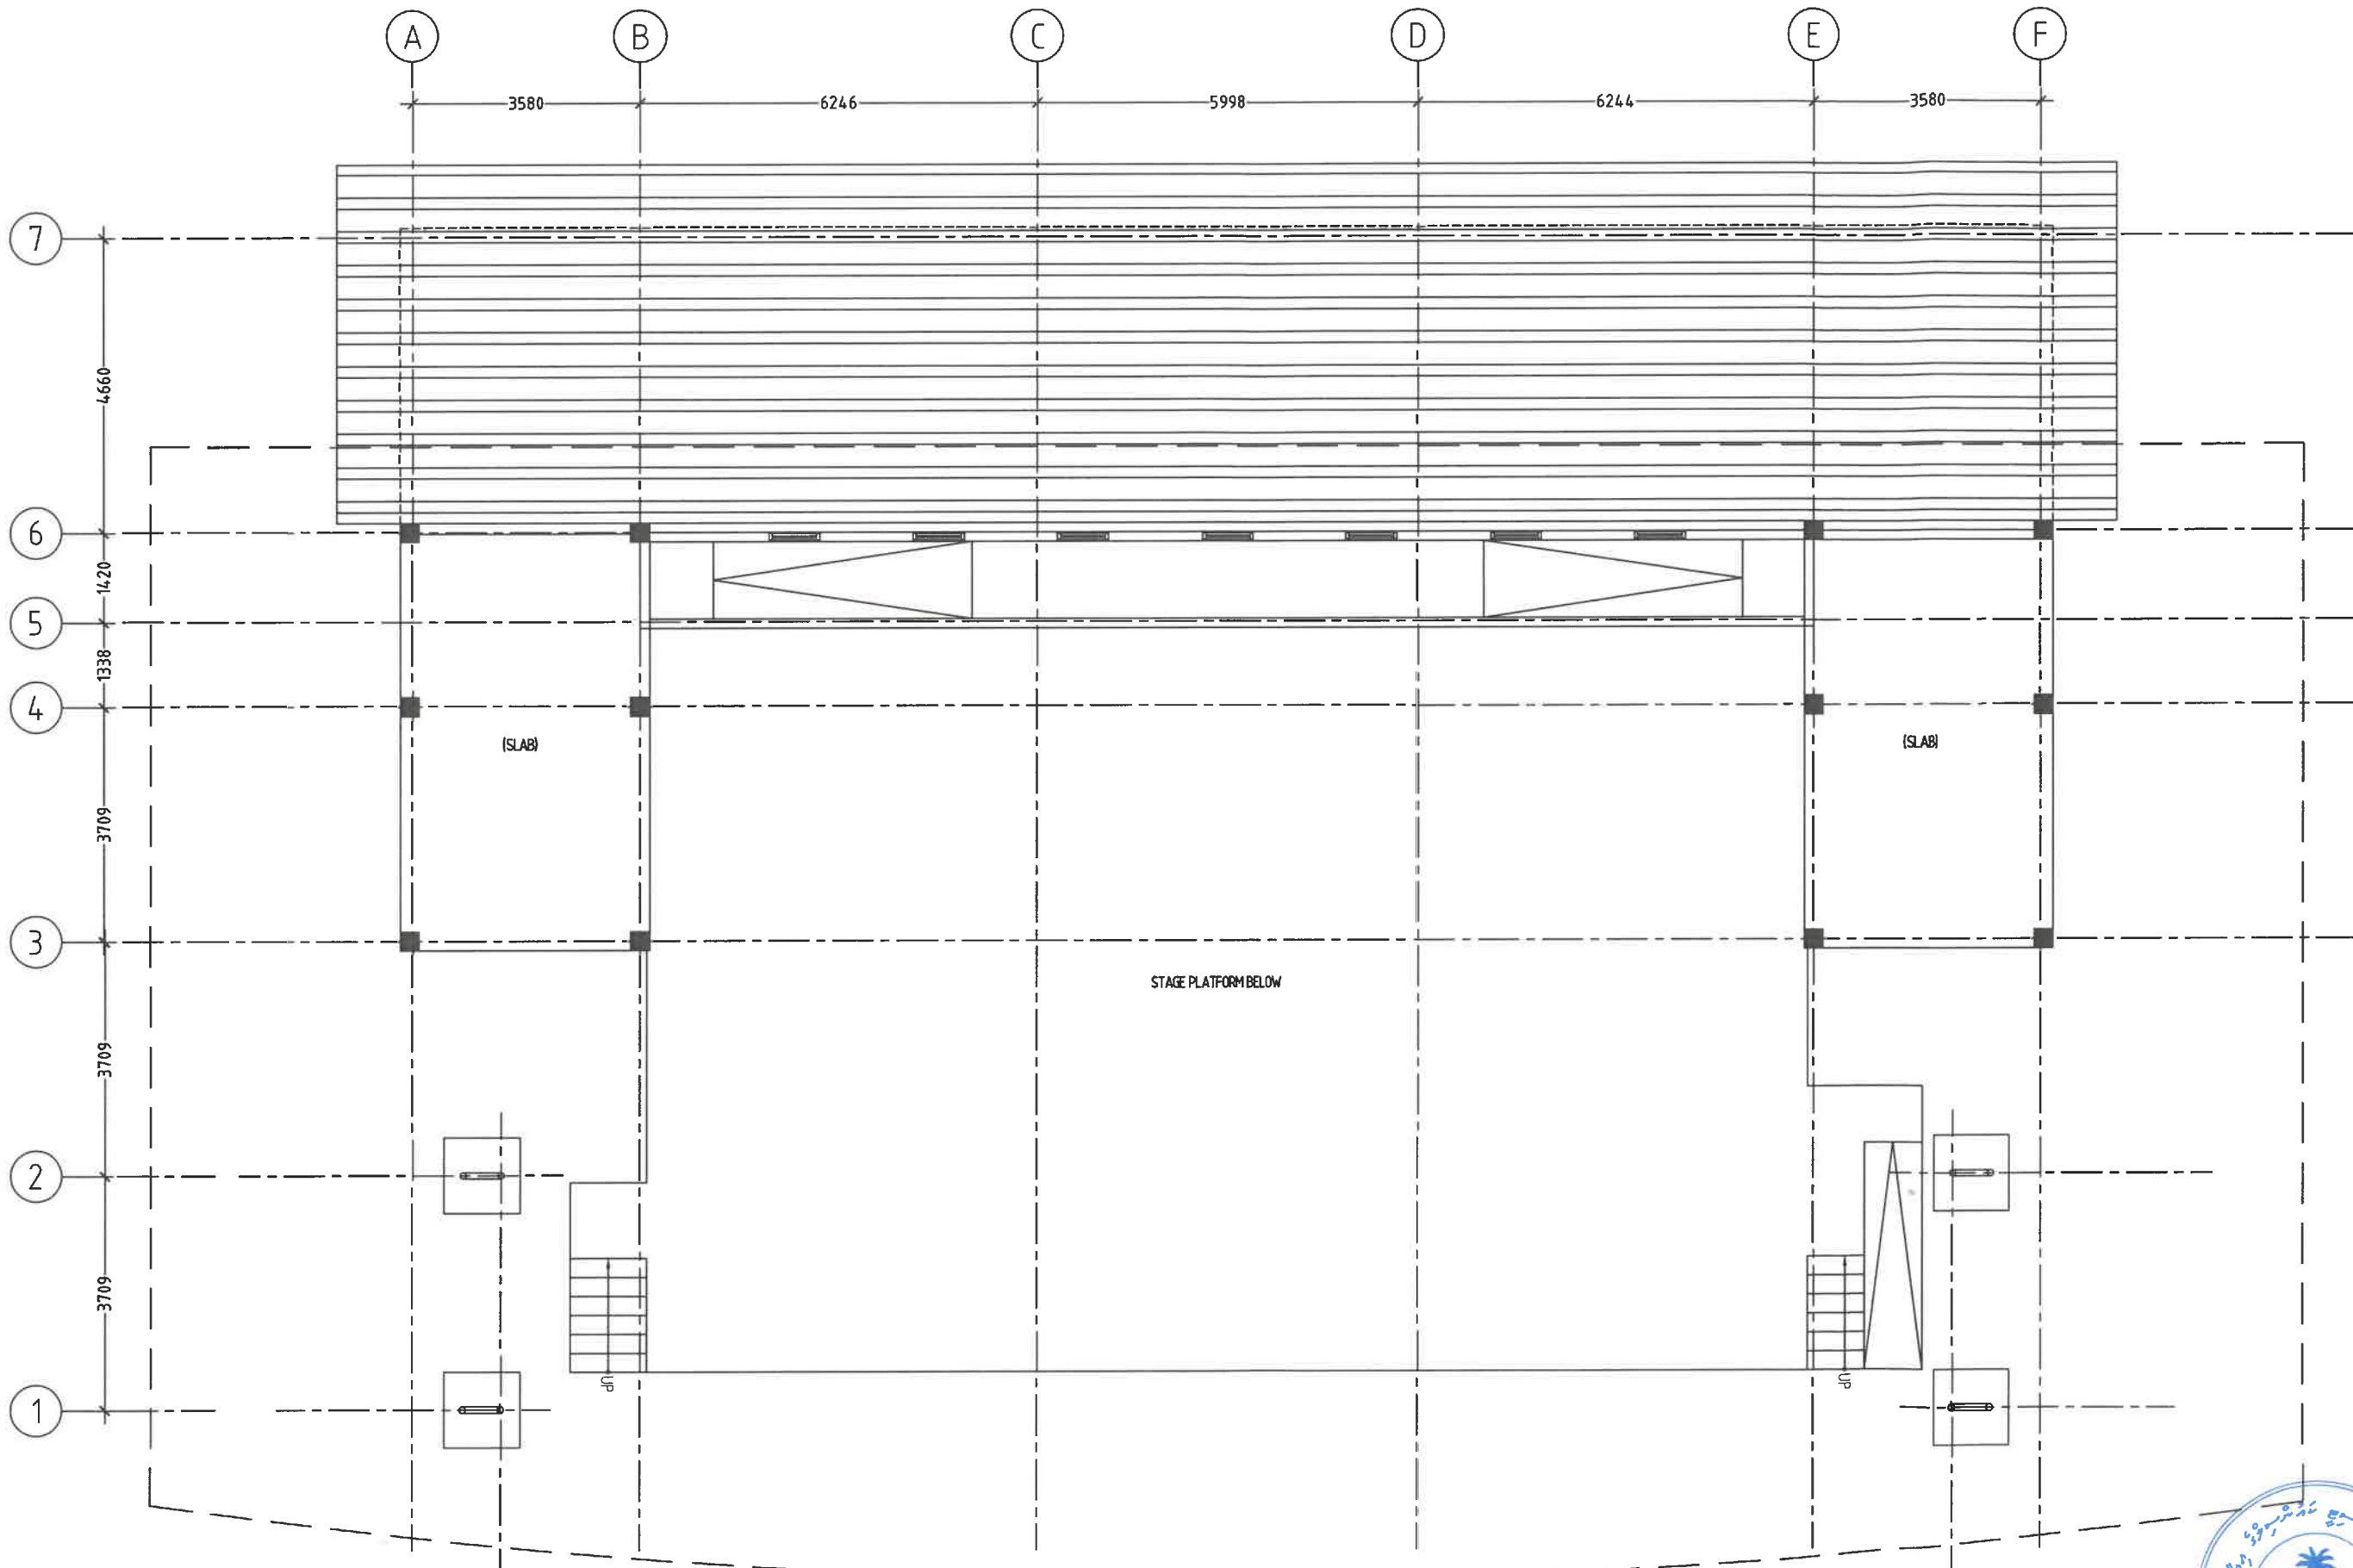


FLOOR PLAN-2  
SCALE 1:100

FLOOR PLAN -2






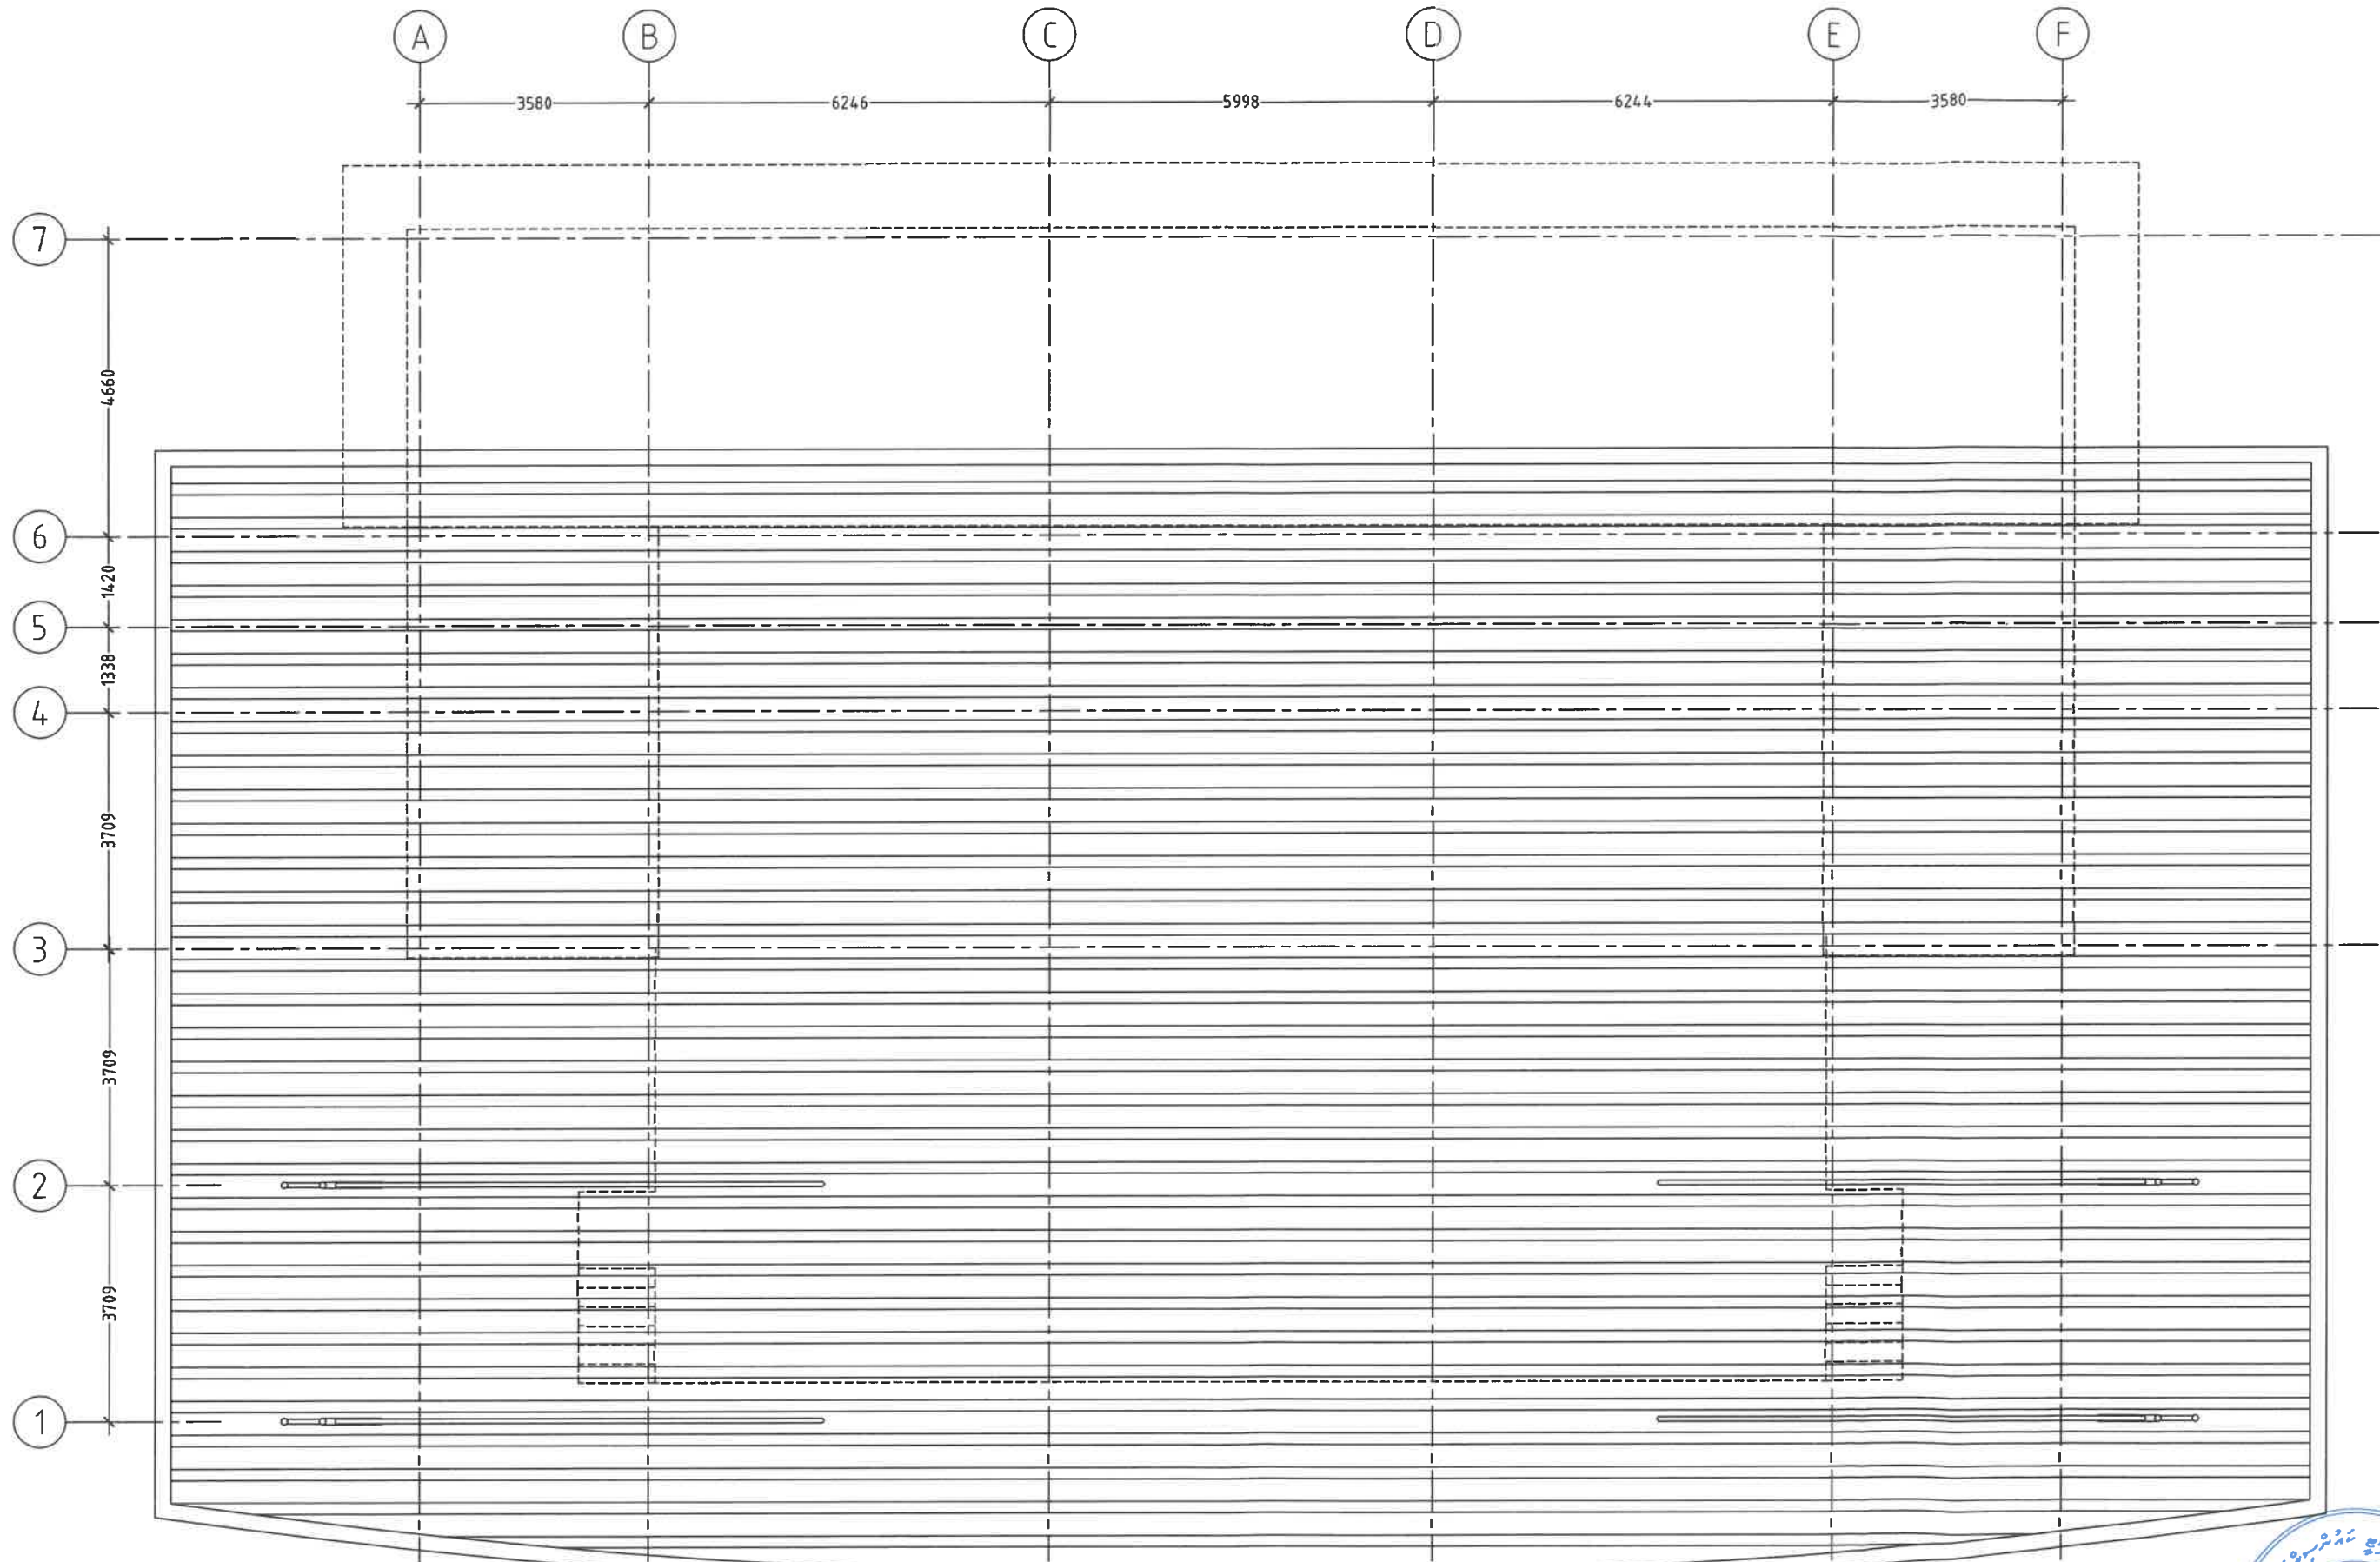

ROOF PLAN  
SCALE 1:100

ROOF PLAN




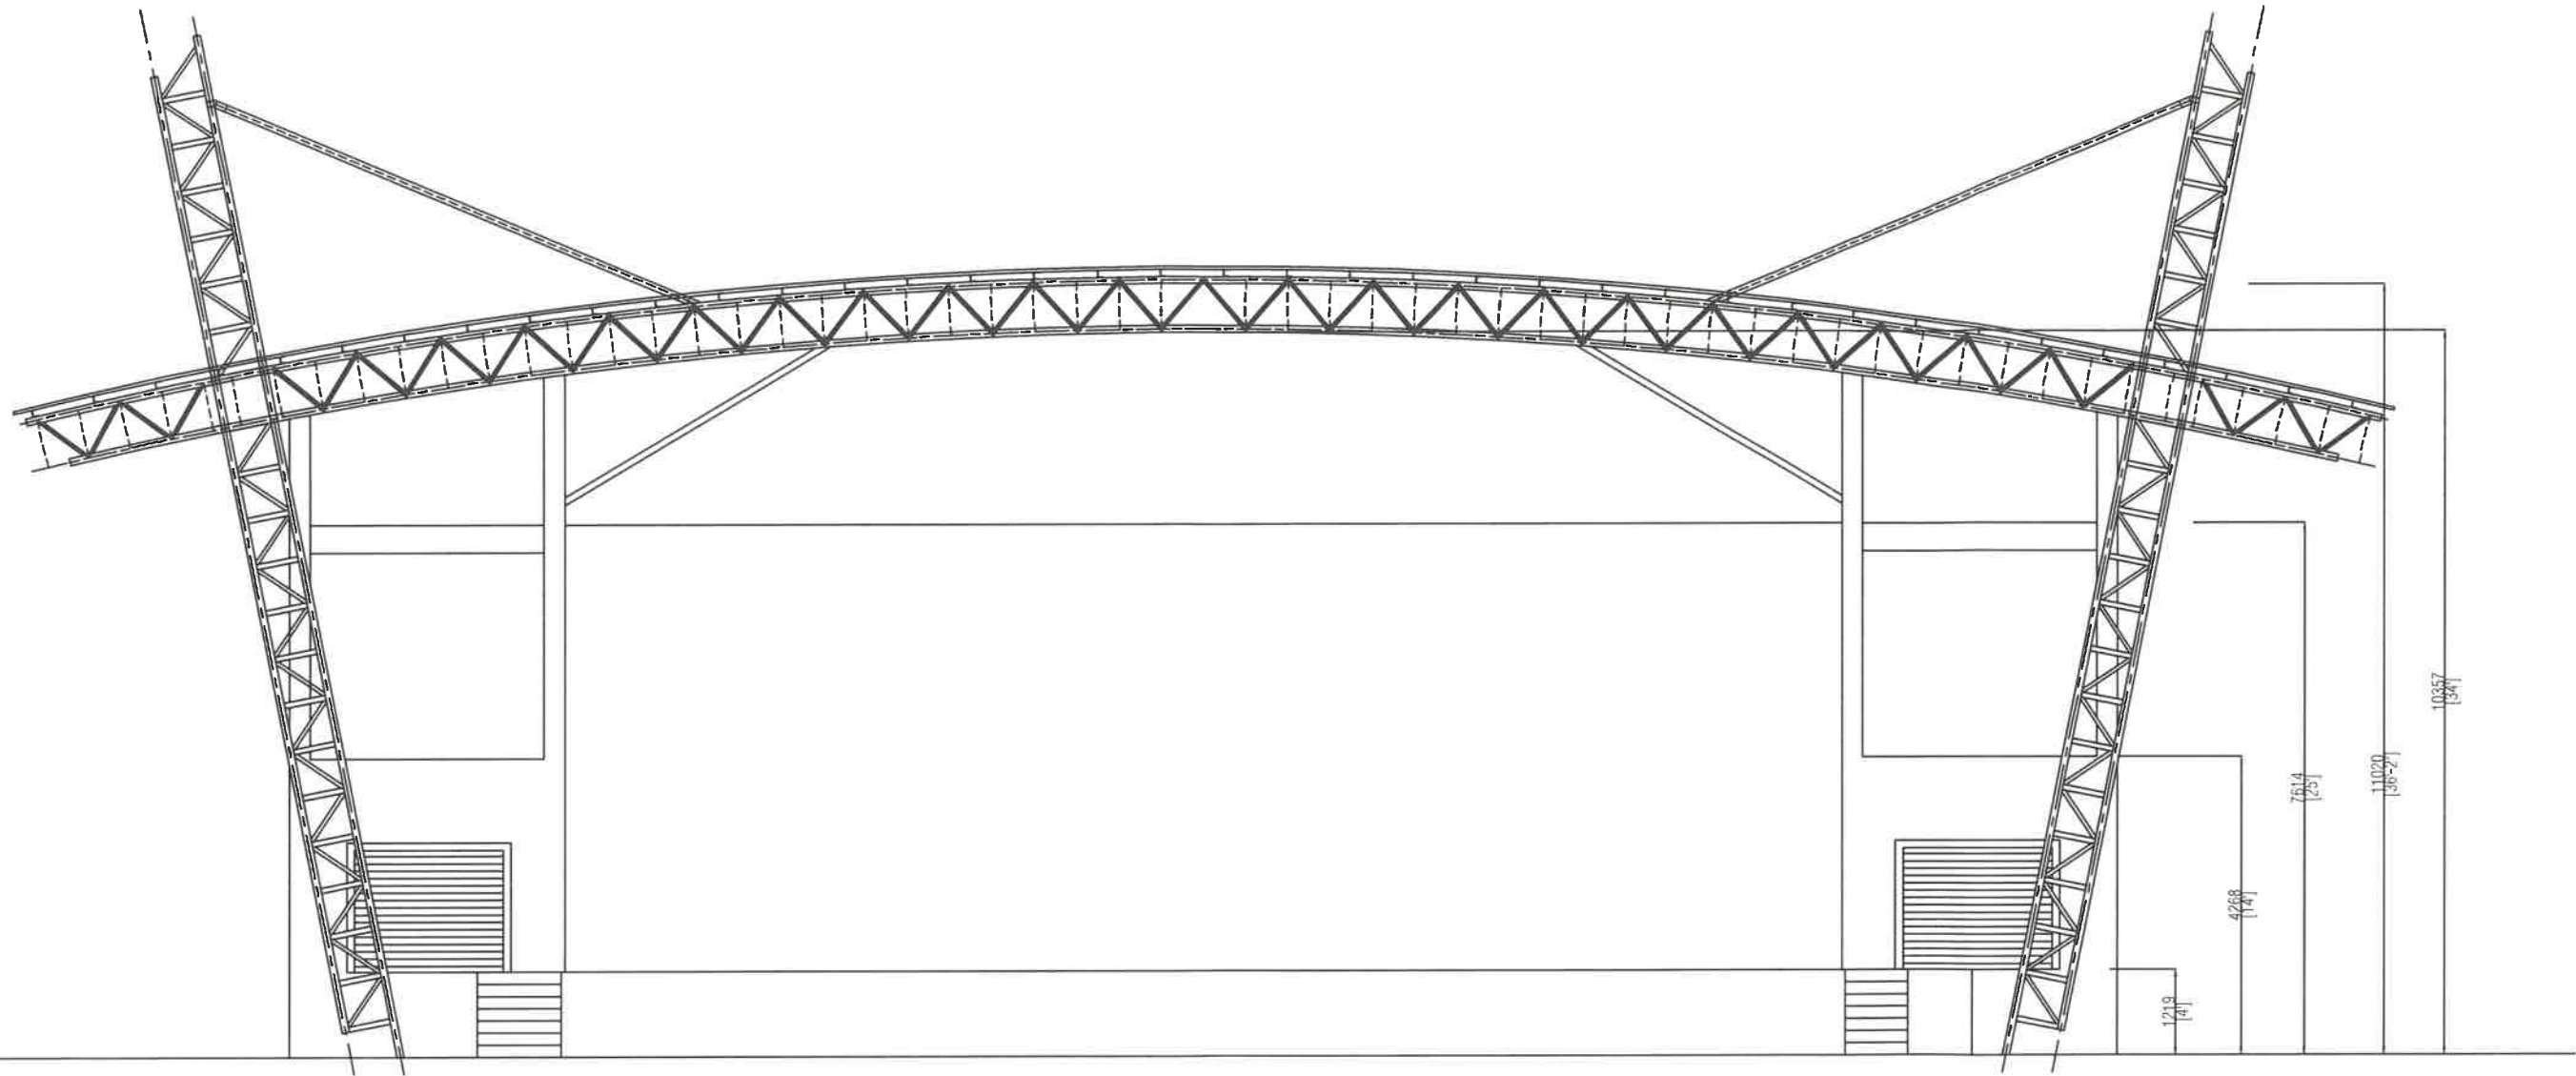


FRONT ELEVATION  
SCALE 1:100



FRONT ELEVATION

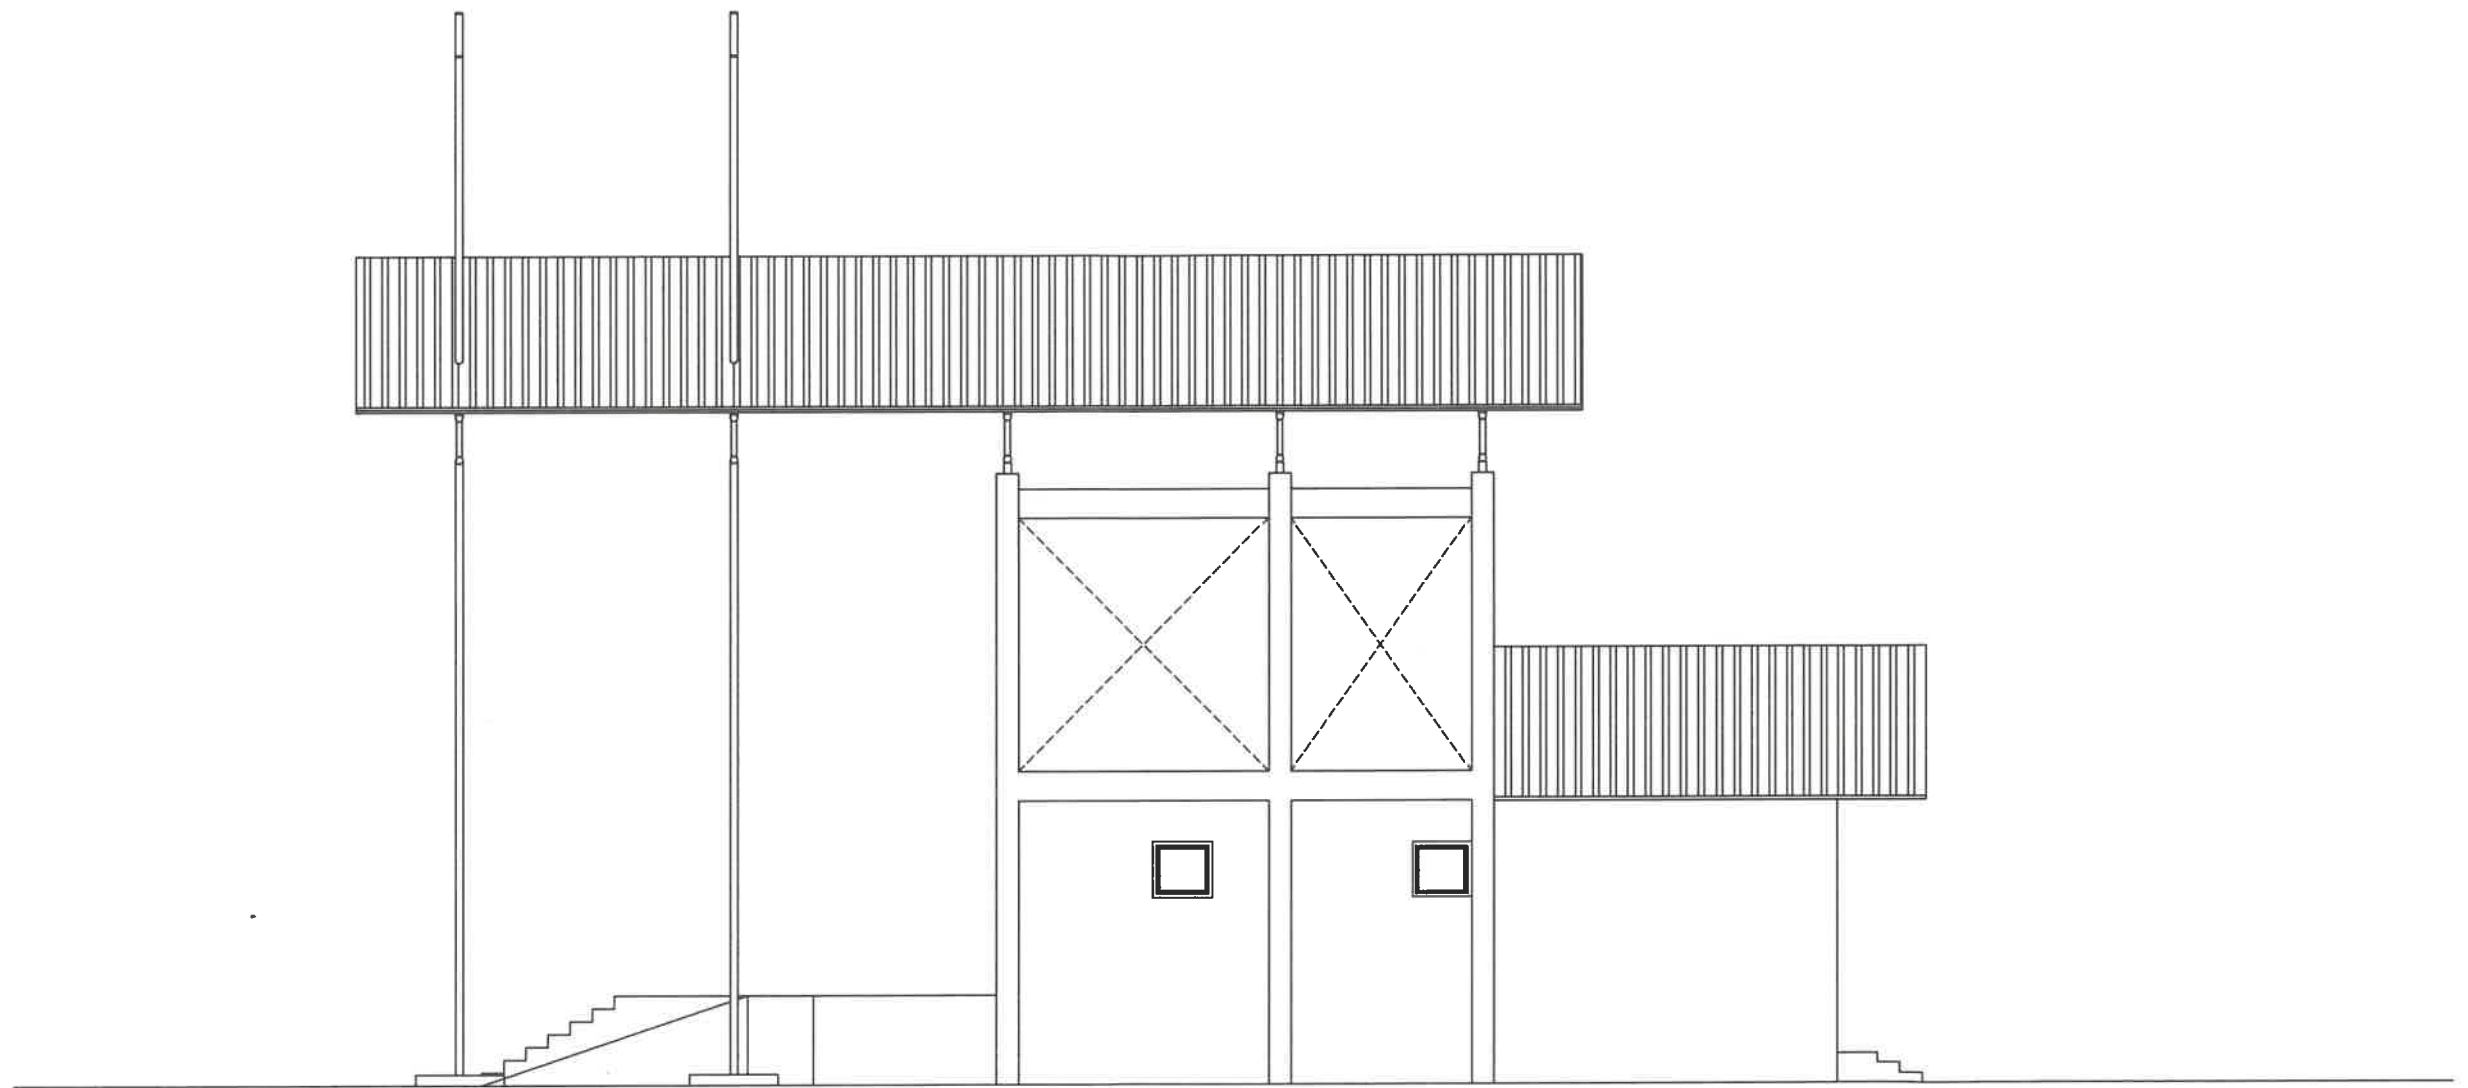

SIDE ELEVATION  
SCALE 1:100

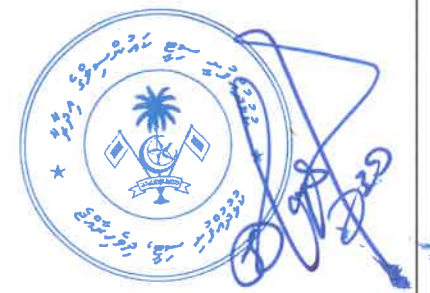

**SIDE ELEVATION**





	D1	D2	D3	D4	
ELEVATION					
FFL					
SIZE	1600 X 2125	3708 X 2125	850 X 2150	650 X 2150	650 X 2150
FRAME	TIMBER	TIMBER	TIMBER	TIMBER	TIMBER
GLAZING	DECORATED TIMBER PANEL	DECORATED TIMBER PANEL	DECORATED TIMBER PANEL	DECORATED TIMBER PANEL	DECORATED TIMBER PANEL






	W1	W2	V1	V2
ELEVATION				
FFL	1000	1000	1850	1850
SIZE	2069 X 1600	1200 X 1600	500 X 750	800 X 750
FRAME	ALUMINUM (WHITE POWDER COATED)	ALUMINUM (WHITE POWDER COATED)	ALUMINUM (WHITE POWDER COATED)	ALUMINUM (WHITE POWDER COATED)
GLAZING	3mm THK. CLEAR GLASS	3mm THK. CLEAR GLASS	3mm THK. CLEAR GLASS	3mm THK. CLEAR GLASS

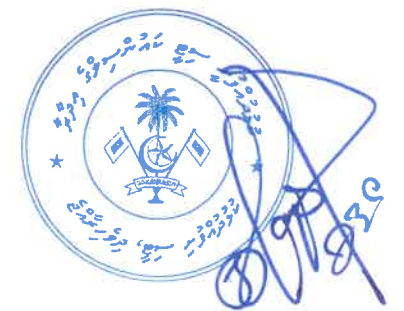

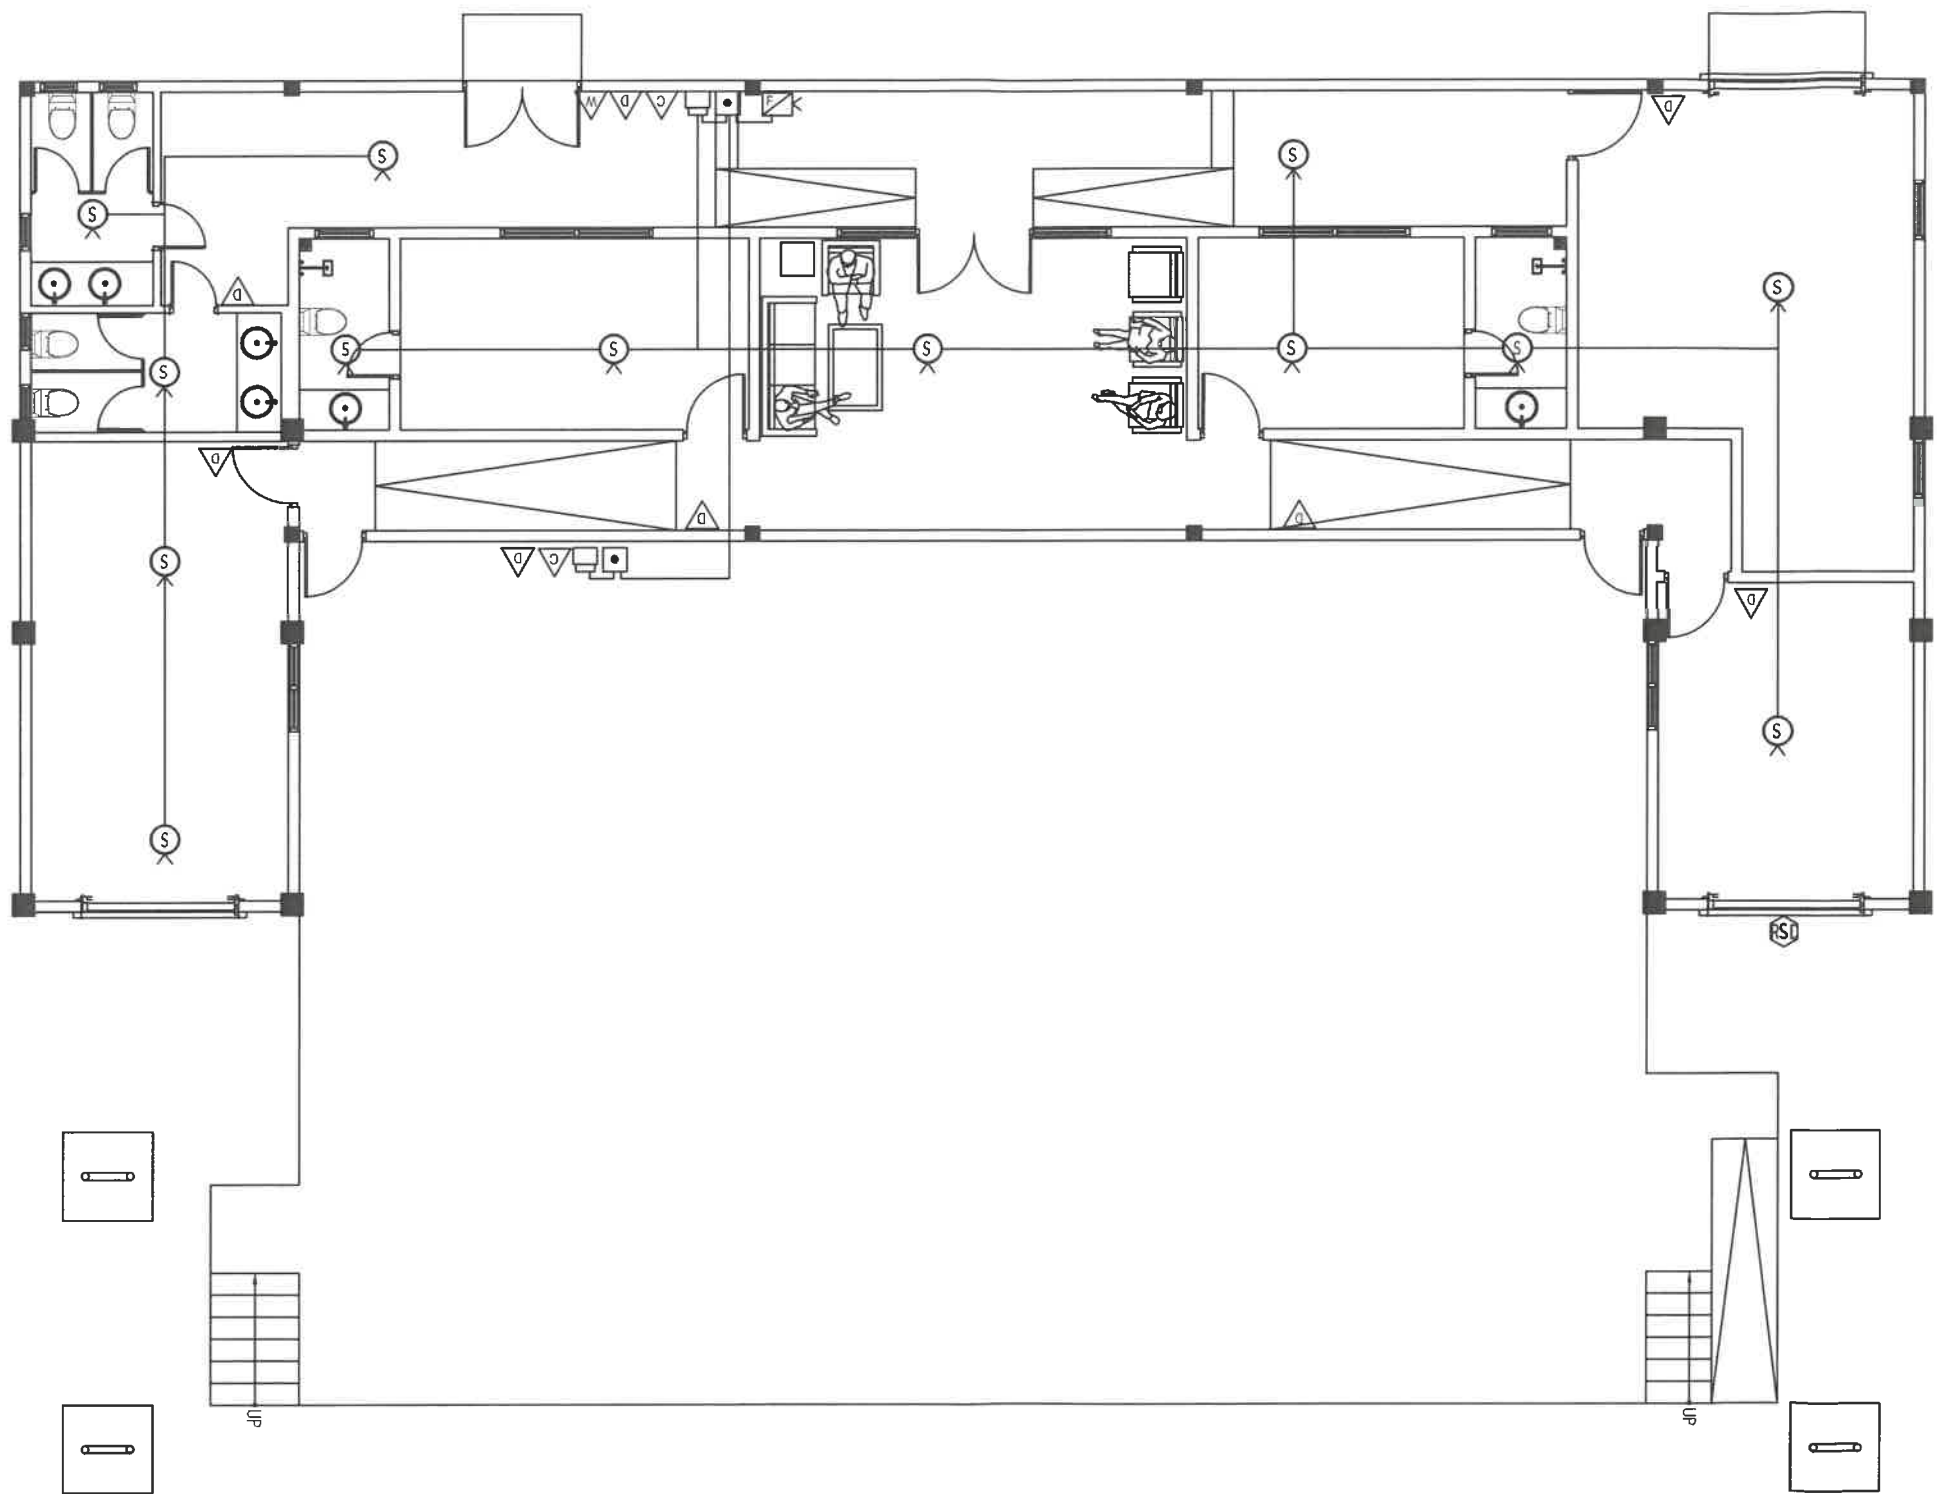



 


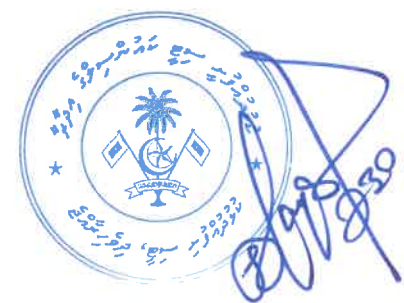










 




 


 



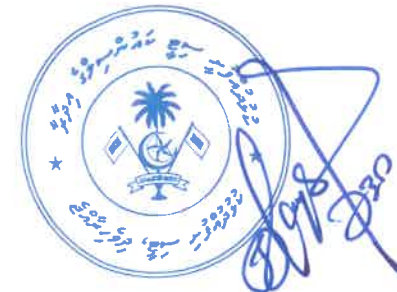
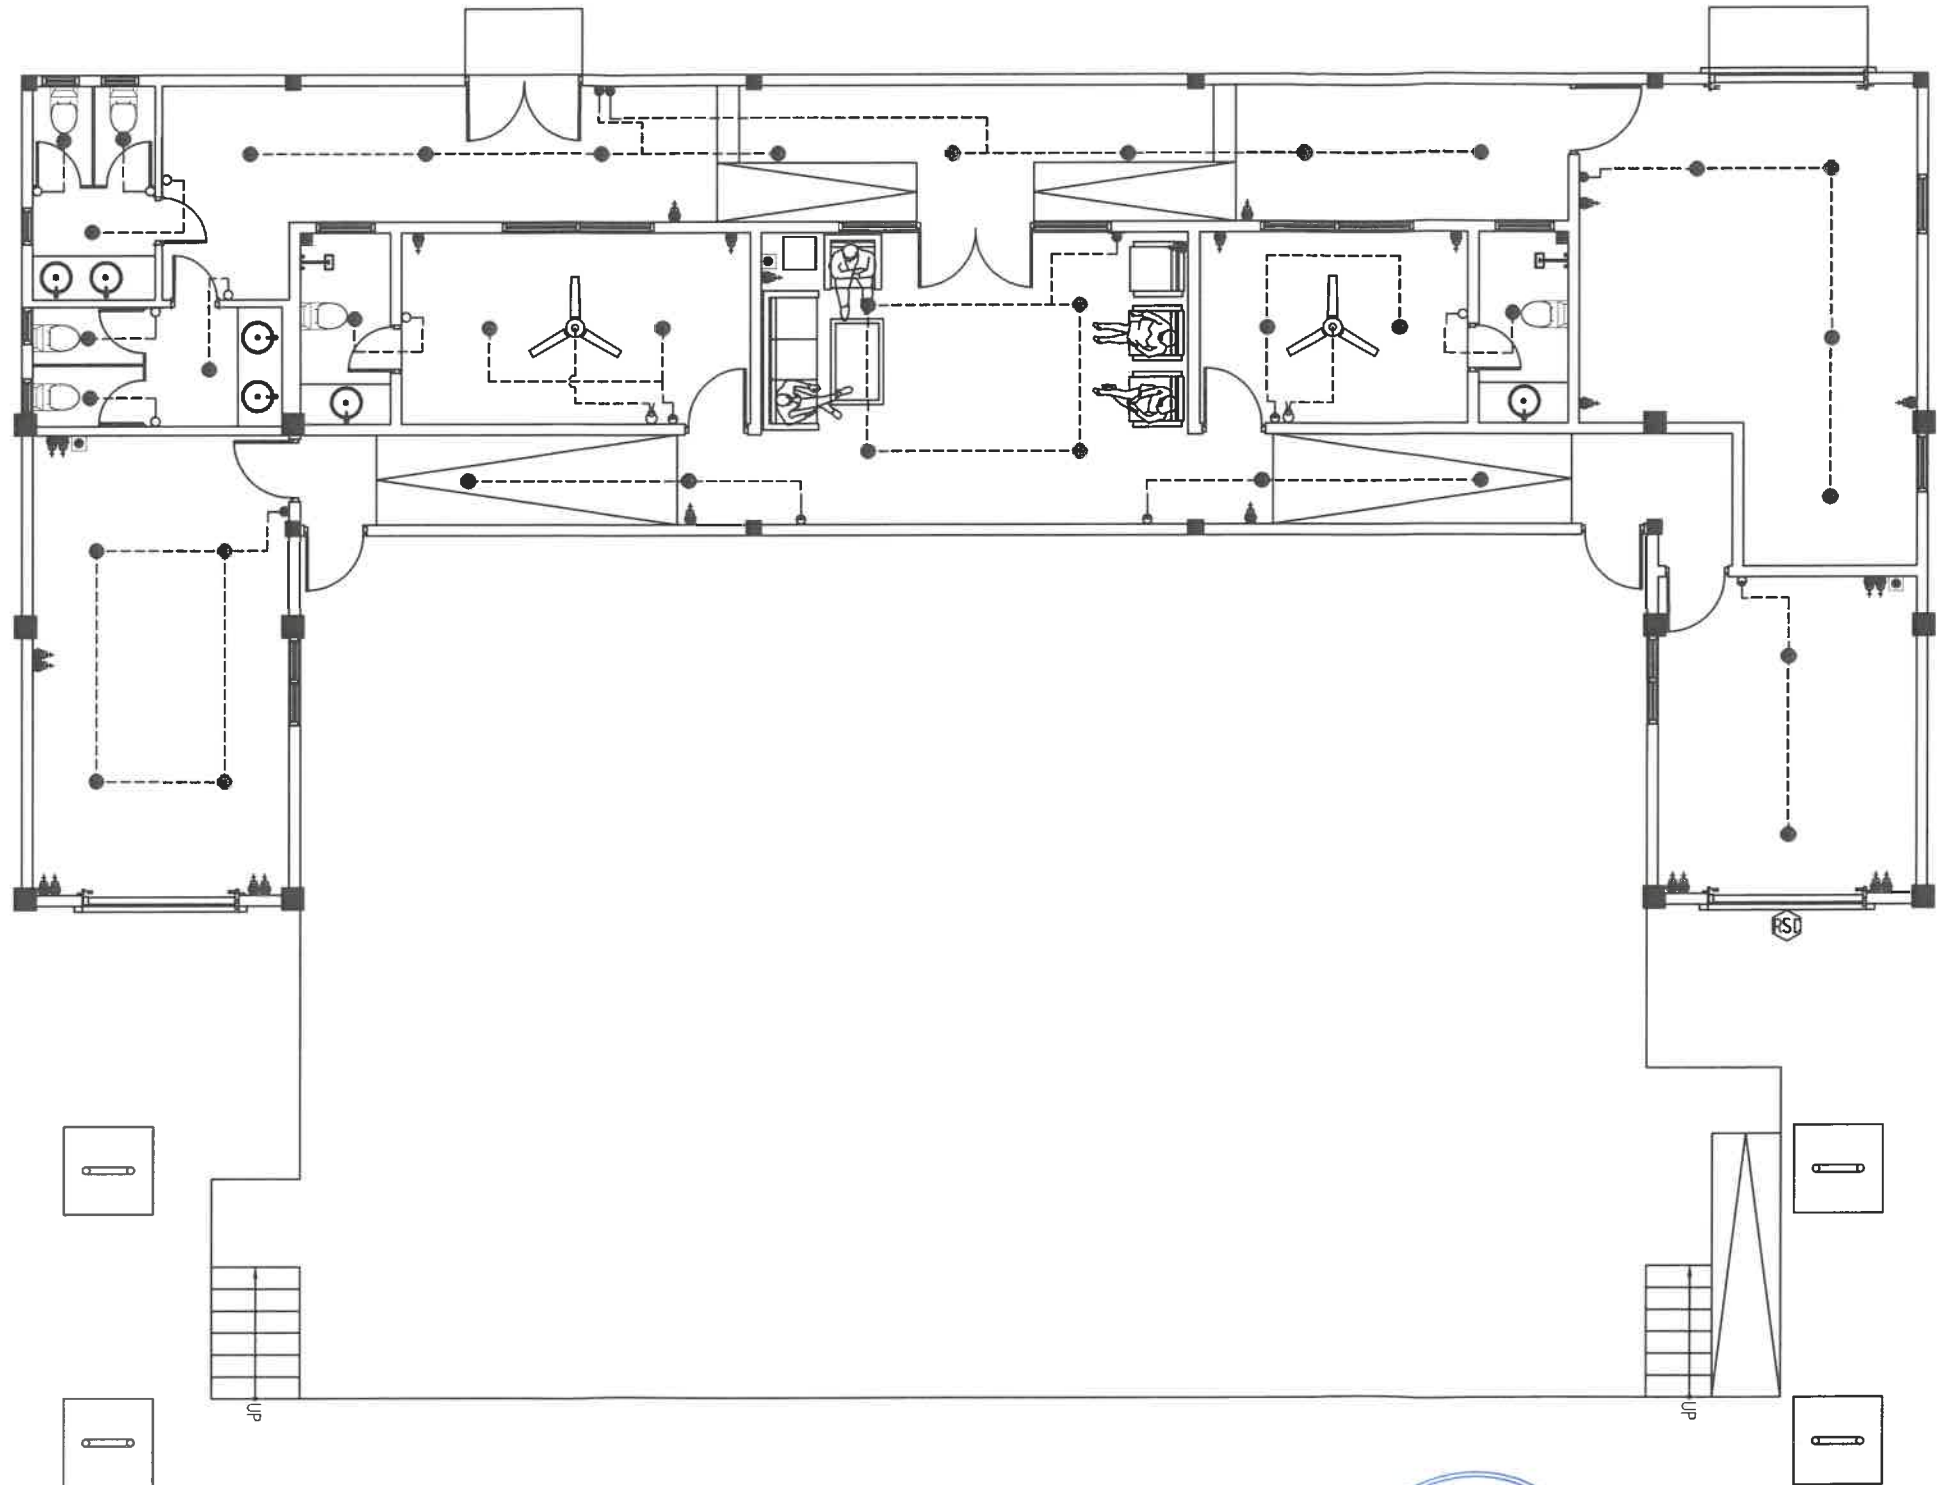
**FIRE FIGHTING LAYOUT**


SCALE 1:100




**ELECTRICAL LEGEND**

-  CEILING MOUNT LIGHT
-  WALL MOUNT LIGHT
-  WEATHER PROOF MOUNT LIGHT
-  WEATHER PROOF MOUNT LIGHT
-  SOFFIT MOUNT WEATHER PROOF LIGHT
-  FAN SWITCH /REGULATOR
-  TWO GANG SWITCH 1.2MH
-  THREE GANG SWITCH 1.2MH
-  ONE WAY SWITCH 1.2MH
-  MASTER SWITCH
-  TELEPHONE/CAT5 SOCKET
-  CABLE TV SOCKET OUTLET
-  WALL SOCKET OUTLET (SINGLE 13A AT 300mm)
-  WALL SOCKET OUTLET (DOUBLE 13A AT 300mm)
-  WALL SOCKET OUTLET (DOUBLE 13A AT 1000mm)
-  WALL SOCKET OUTLET (SINGLE 13A AT 2500mm)
-  WALL SOCKET OUTLET (SERVICE 15A)
-  WALL SOCKET OUTLET 13A (ONE GANG)  
FOR HOOD(1800mm H) / IGNITION(300mmH)
-  WEATHERPROOF GARDEN LIGHT  
DOWN LIGHT WITH SENSOR(2M H)
-  D-BOARD
-  MAIN PANEL BOARD
-  ELECTRICAL METER
-  DOOR PHONE SYSTEM
-  CCTV
-  ELECTRONIC LOCK SYSTEM
-  SECURITY MONITORING SYSTEM
-  POOL LIGHT
-  KEY CARD POWER SWITCH




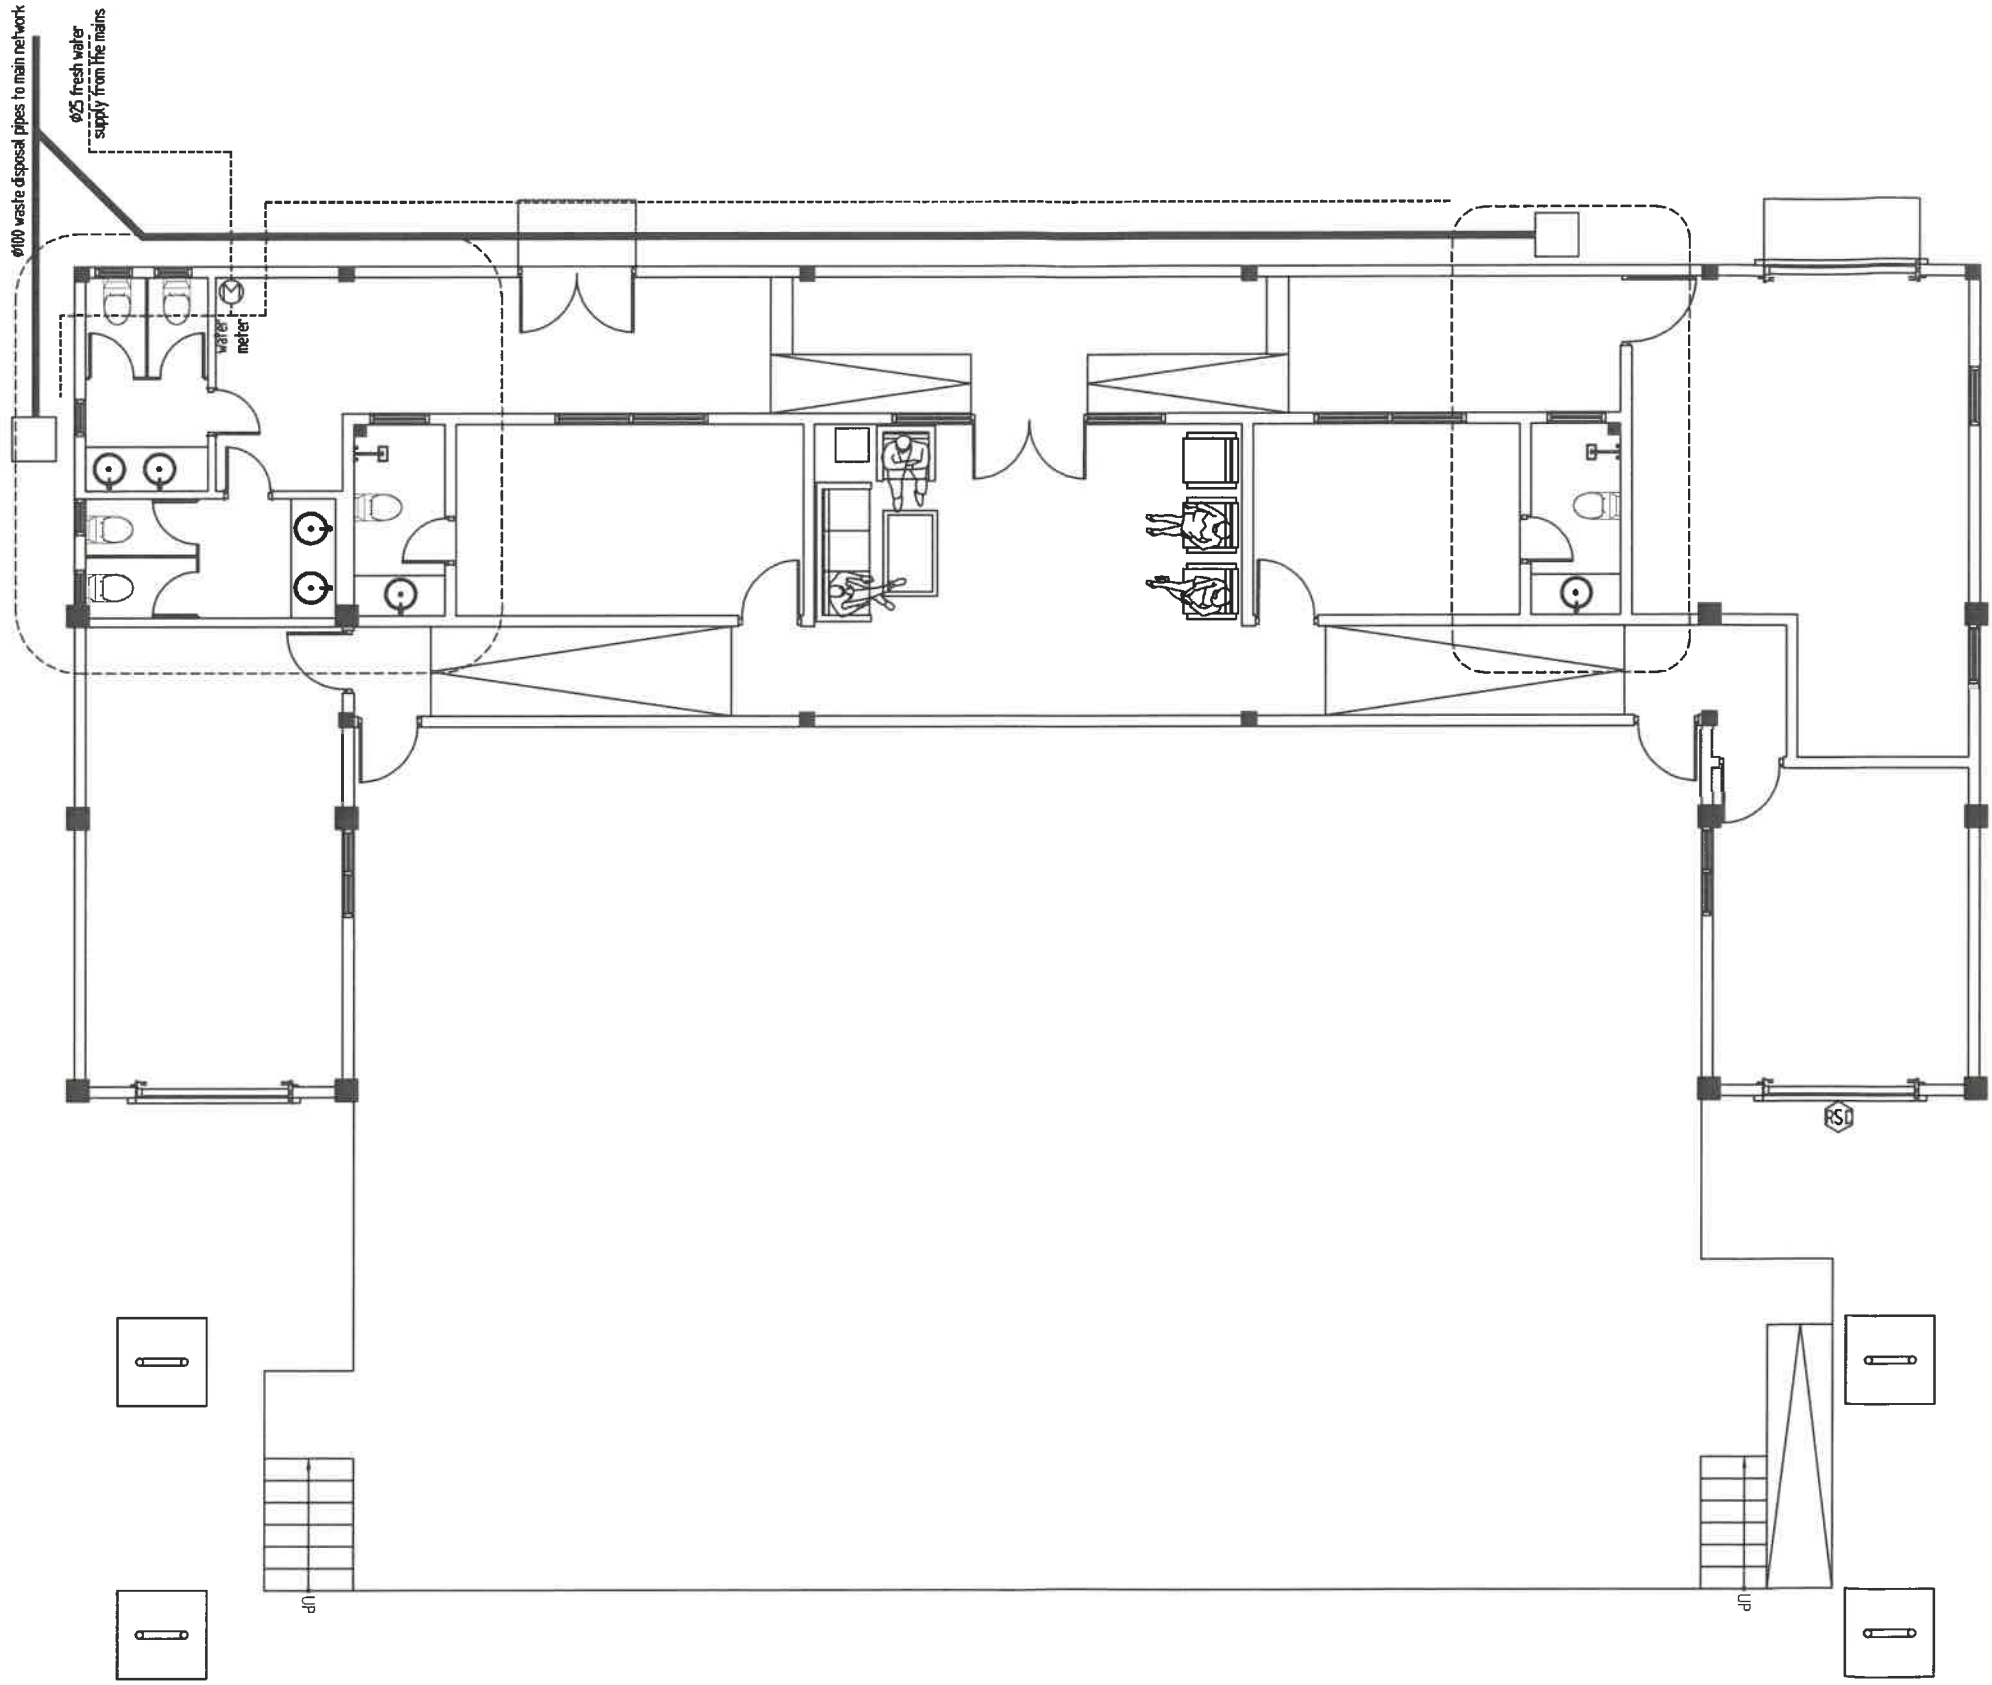



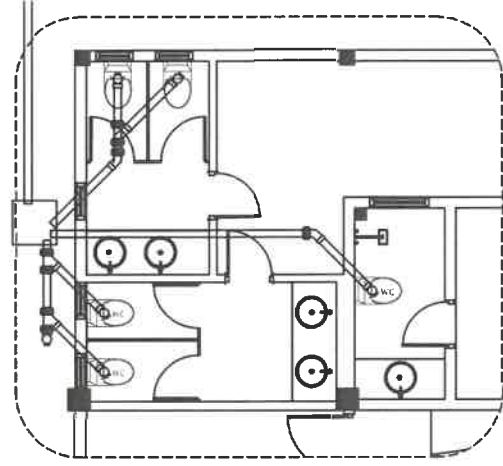


**DETAIL-1**  
**SEWAGE DISPOSAL LAYOUT**  
SCALE 1/50

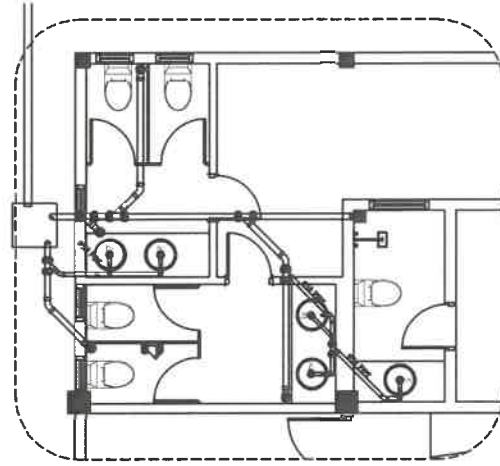


**DETAIL-1**  
**WASTE WATER DISPOSAL LAYOUT**  
SCALE 1/50


WC- WATER CLOSE  
 bs- WASH BASIN WITH TAP  
 FD- FLOOR DRAIN  
 ms- MUSLIM SHOWER  
 t- WATER TAP  
 v- VALVE  
 sh- HEAD SHOWER  
 ks - KITCHEN SINK WITH TAP

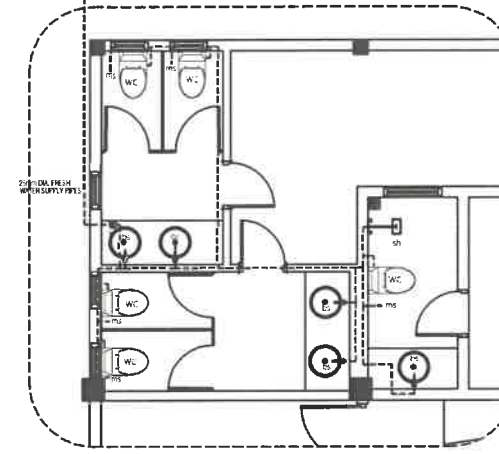


**DETAIL-1**  
**FRESH WATER SUPPLY LAYOUT**  
SCALE 1/50

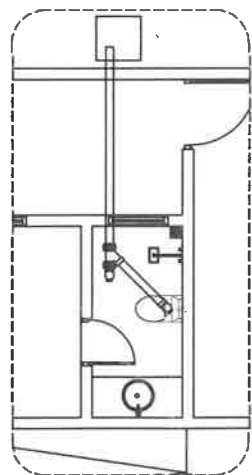


**DETAIL-2**  
**SEWAGE DISPOSAL LAYOUT**  
SCALE 1/50

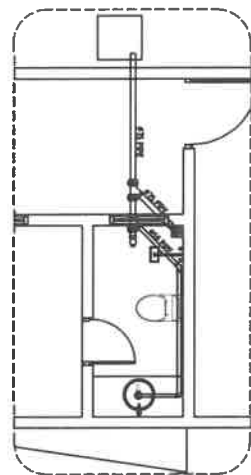


**DETAIL-2**  
**WASTE WATER DISPOSAL LAYOUT**  
SCALE 1/50

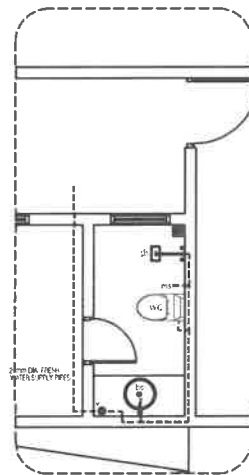

 **DETAIL-1**  
**FRESH WATER SUPPLY LAYOUT**  
SCALE 1/50

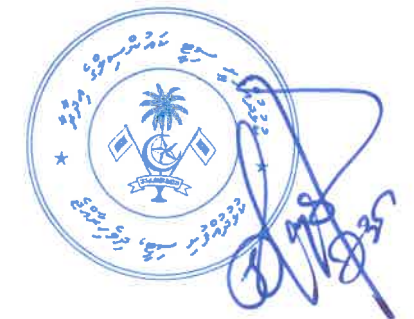



IZZUDDIN MAGU (50 FEET)

3559  
[11'-8"]

18052  
[59'-3"]

1000  
[3'-3"]

29033  
[95'-3"]

PROPOSED SITE FOR  
OPEN STAGE  
(524.11 SQM. / 5641.53 SQM.)

PROPOSED ROAD

3559  
[11'-8"]



18052  
[59'-3"]

1000  
[3'-3"]


PROPOSED ROAD



	SECRETARIAT OF THE KULHUDHUFFUSHI CITY COUNCIL	TITLE: SITE PLAN	PROJECT: H.DH KULHUDHUFFUSHI OPEN STAGE	DRAWN AND CHECKED BY:	DATE: 28 MAY 2022
	AMEENEE MAGU, KULHUDHUFFUSHI CITY, 02110, REP. OF MALDIVES TEL: 6528831 EMAIL: INFO@KULHUDHUFFUSHICITY.GOV.MV				SCALE: 1:300

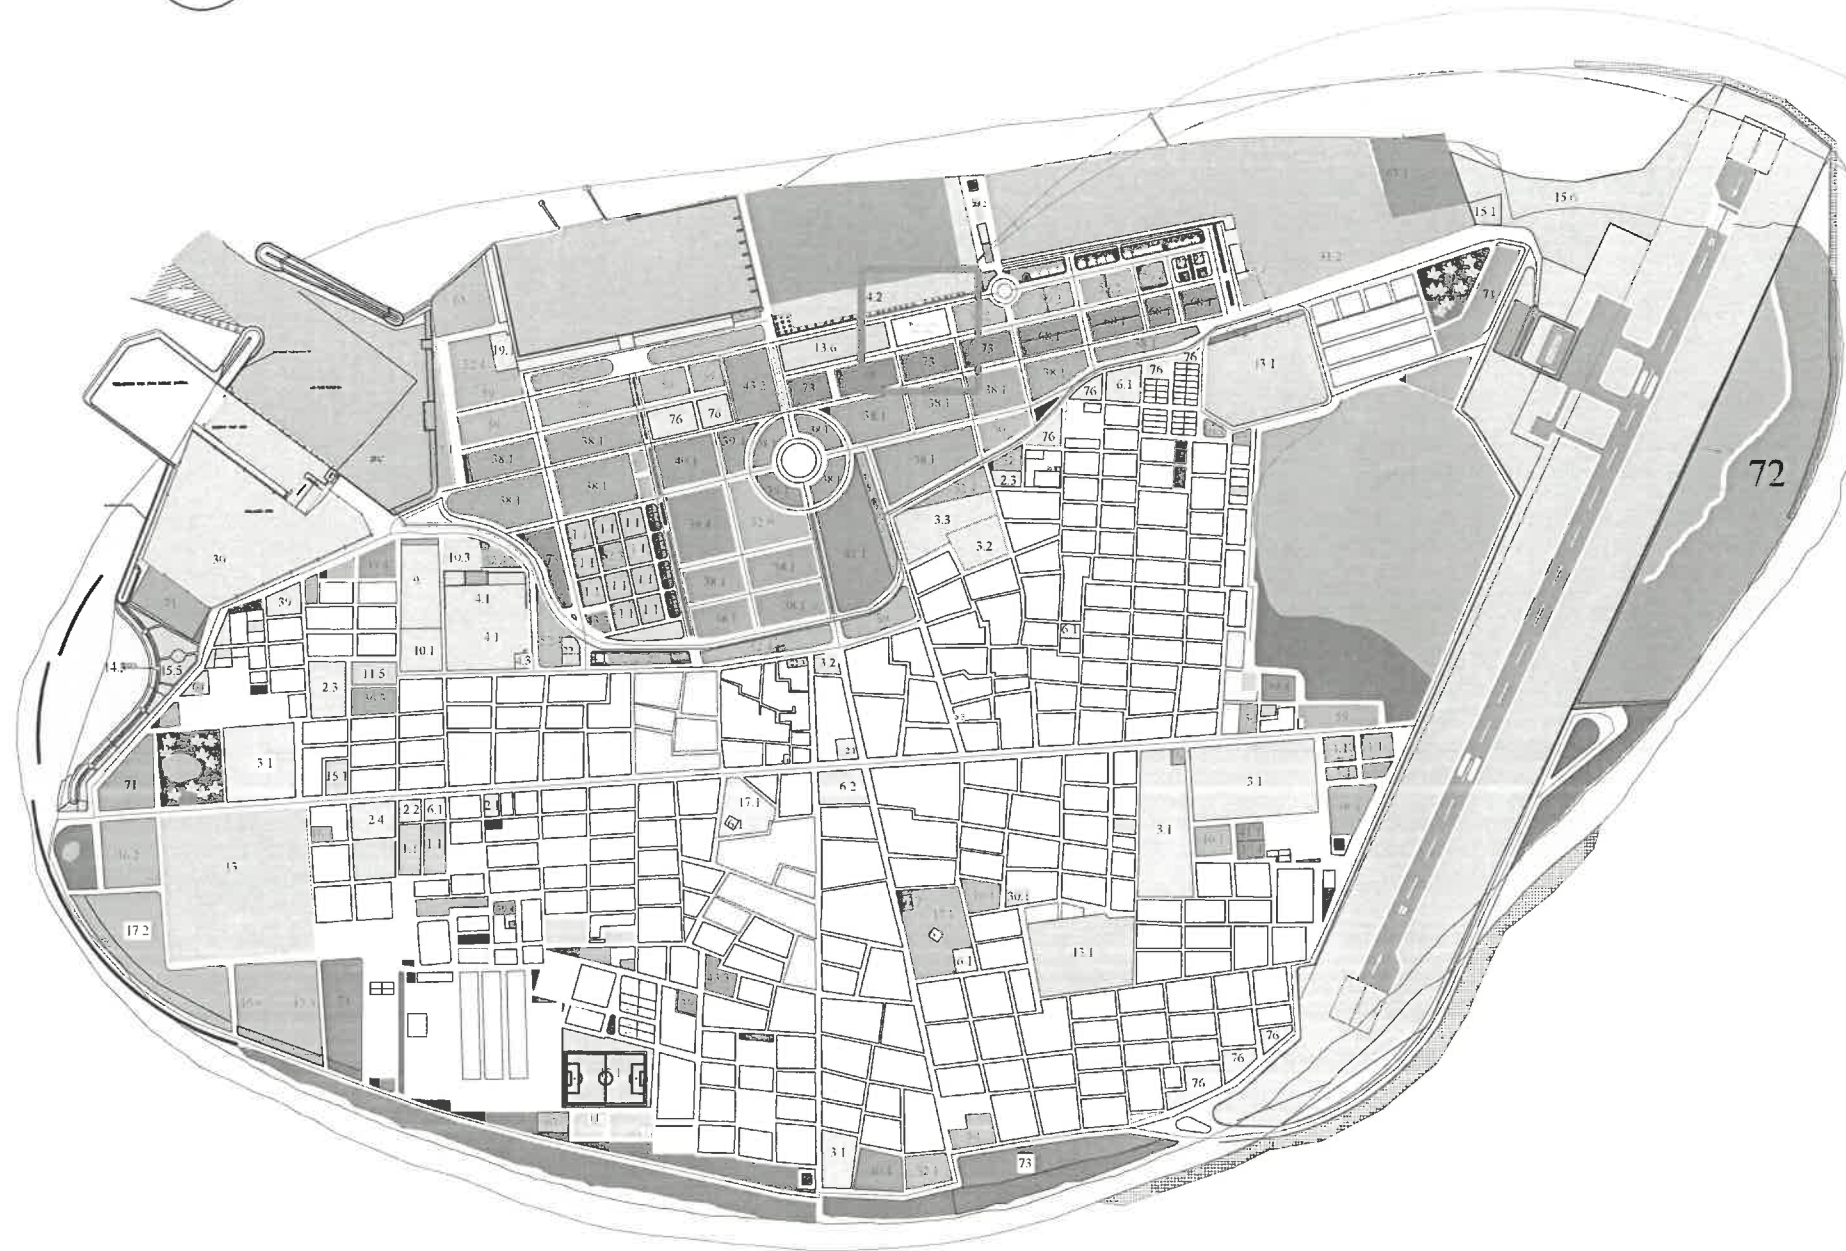 

14.2

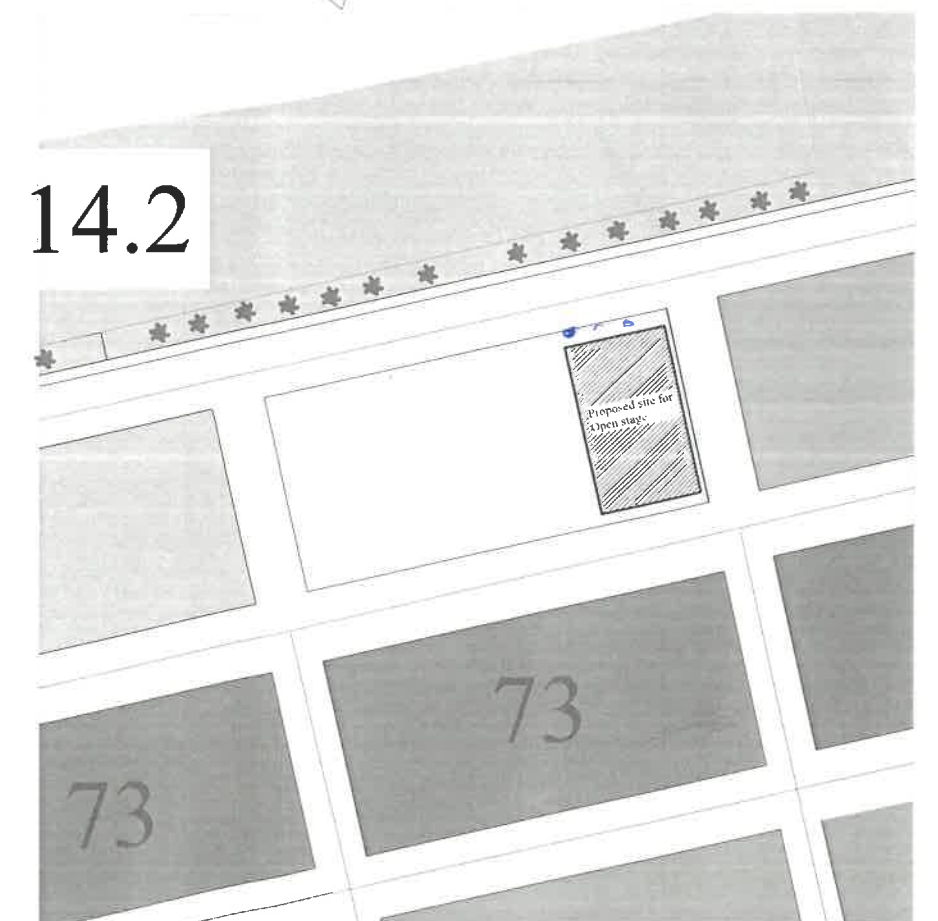

	<p>SECRETARIAT OF THE KULHUDHUFFUSHI CITY COUNCIL</p> <p>AMEENEE MAGU, KULHUDHUFFUSHI CITY, 02110, REP. OF MALDIVES TEL: 6528831 EMAIL: INFO@KULHUDHUFFUSHICITY.GOV.MV</p>	<p><b>TITLE:</b> PROPOSED LOCATION OPEN STAGE</p>	<p><b>PROJECT:</b> OPEN STAGE</p>	<p><b>DRAWN AND CHECKED BY:</b></p>	<p><b>DATE:</b> 28 MAY 2022</p> <p><b>SCALE:</b></p>
--	--	---	---------------------------------------	-------------------------------------	--